

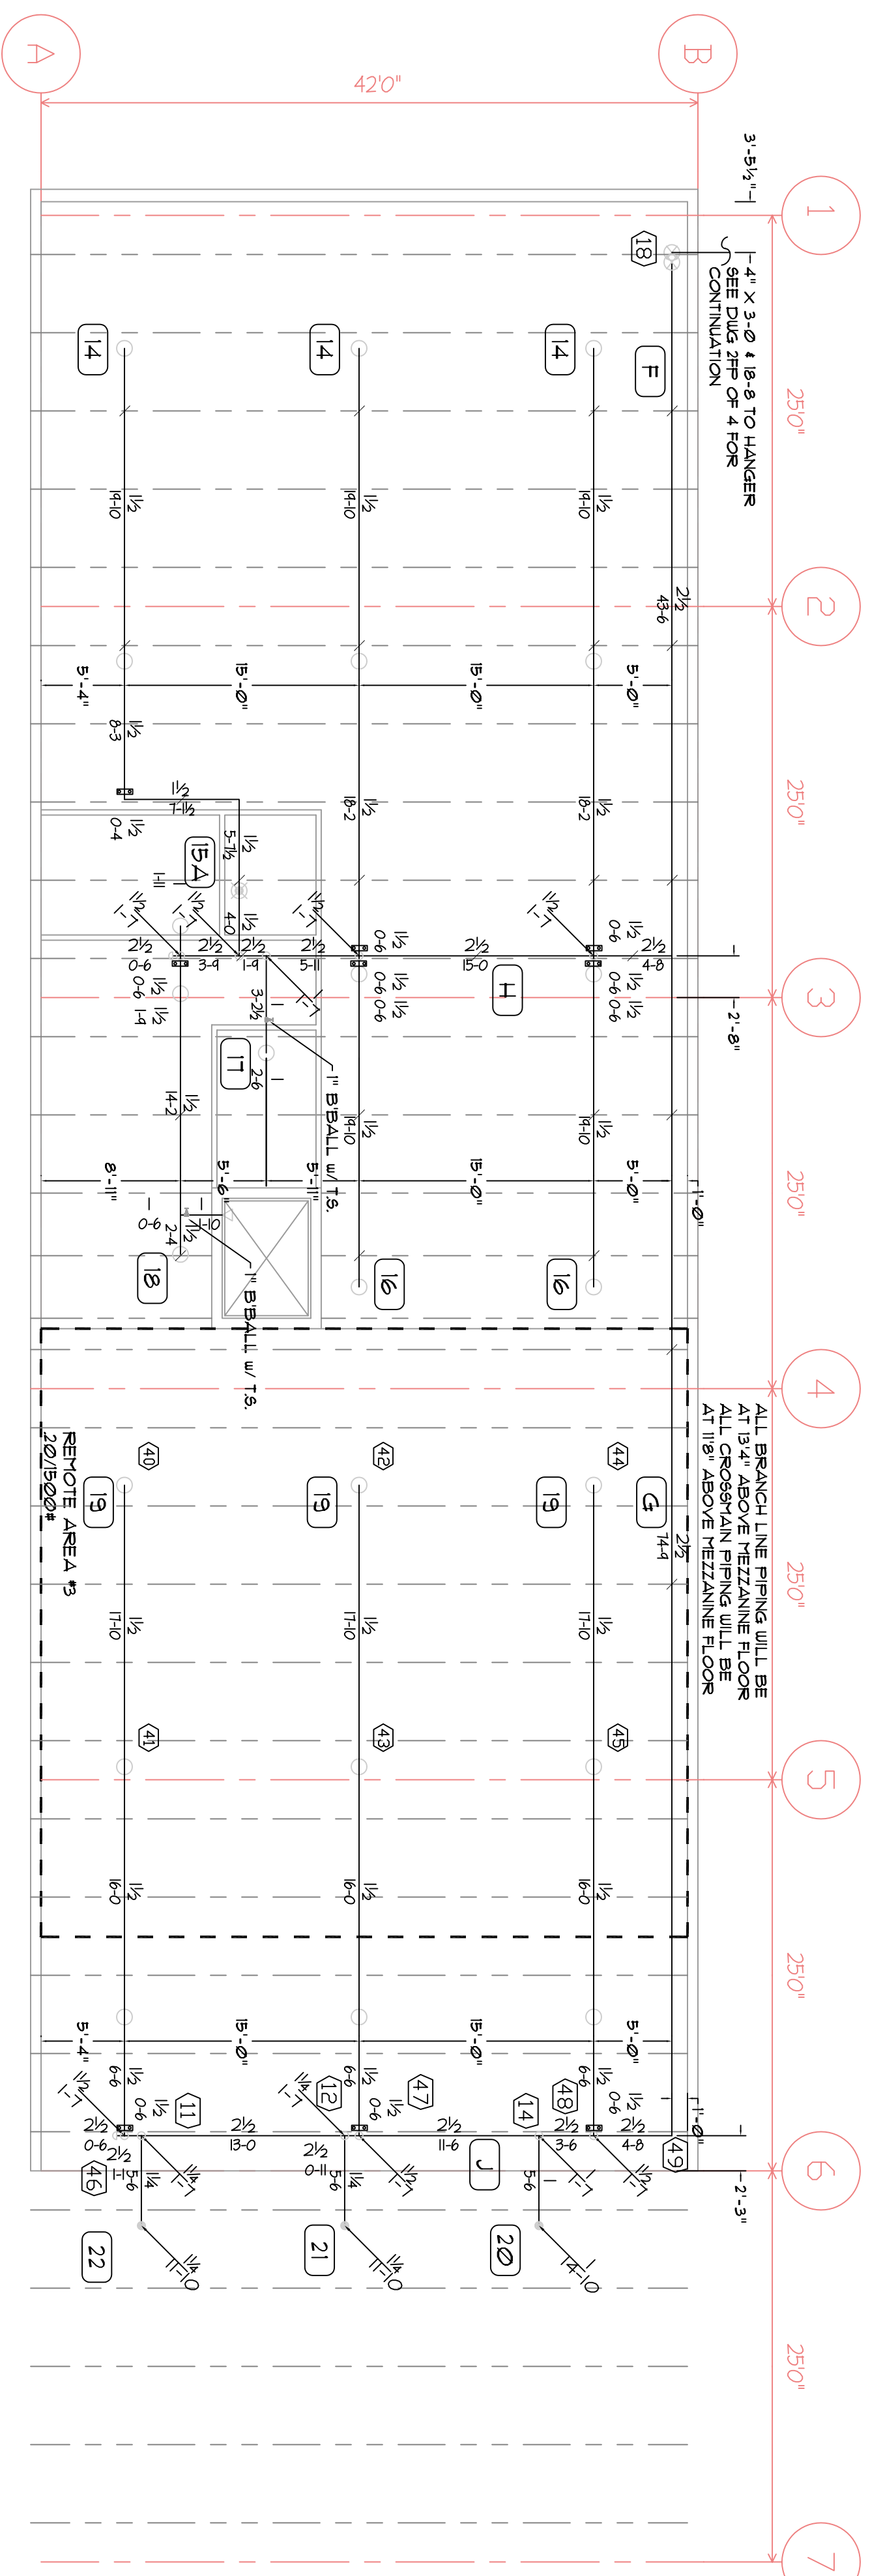
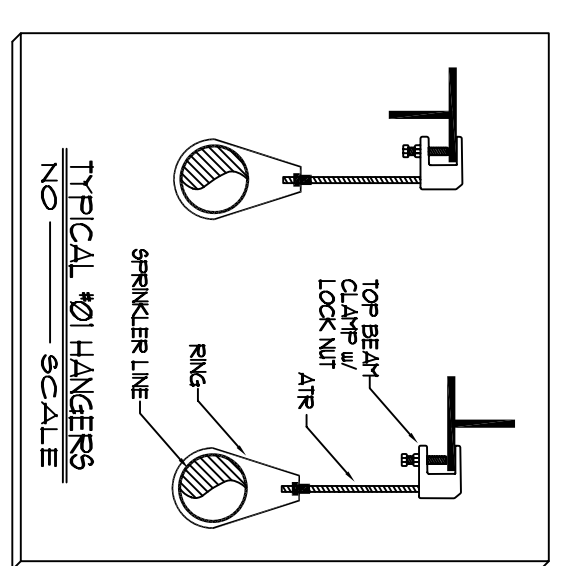


NOTE
SEE SITE PLAN FOR UNDERGROUND PIPING

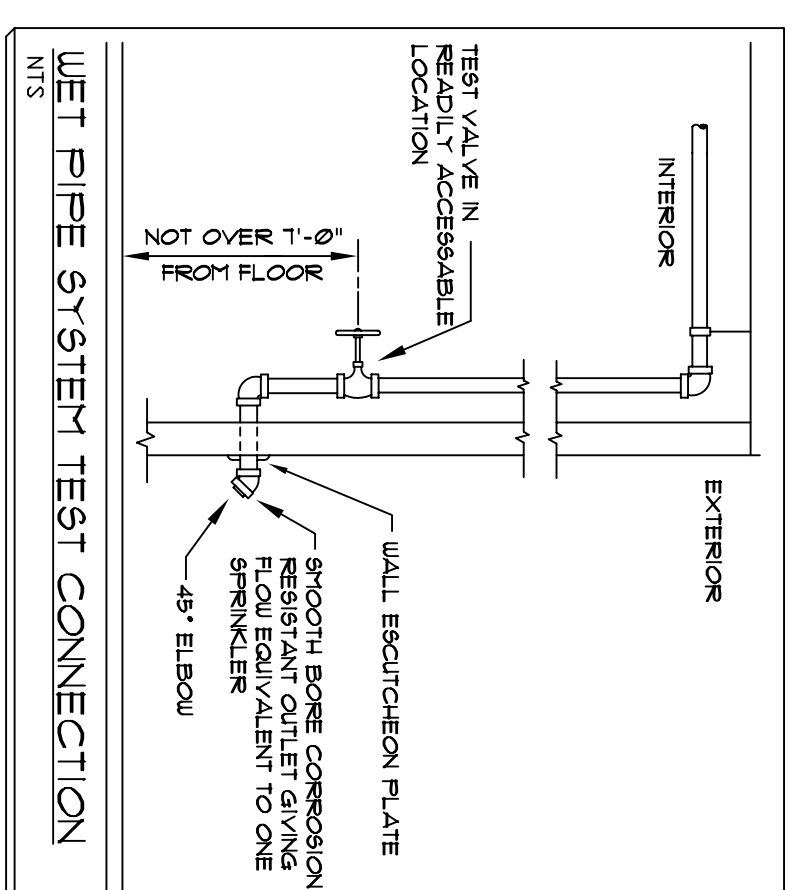


MEZZANINE FIRE PROTECTION PLAN
SCALE: 1/8" = 1'-0"

FOR GENERAL NOTES, HANGER PIPING SECTION VIEW,
AND OFFICE SUPPLY PIPE SEE DUG ZFP OF 4
FOR UNDERGROUND PIPING SEE DUG JFP OF 4
FOR RUP ROOM AND EQUIPMENT SEE DUG AFP OF 4

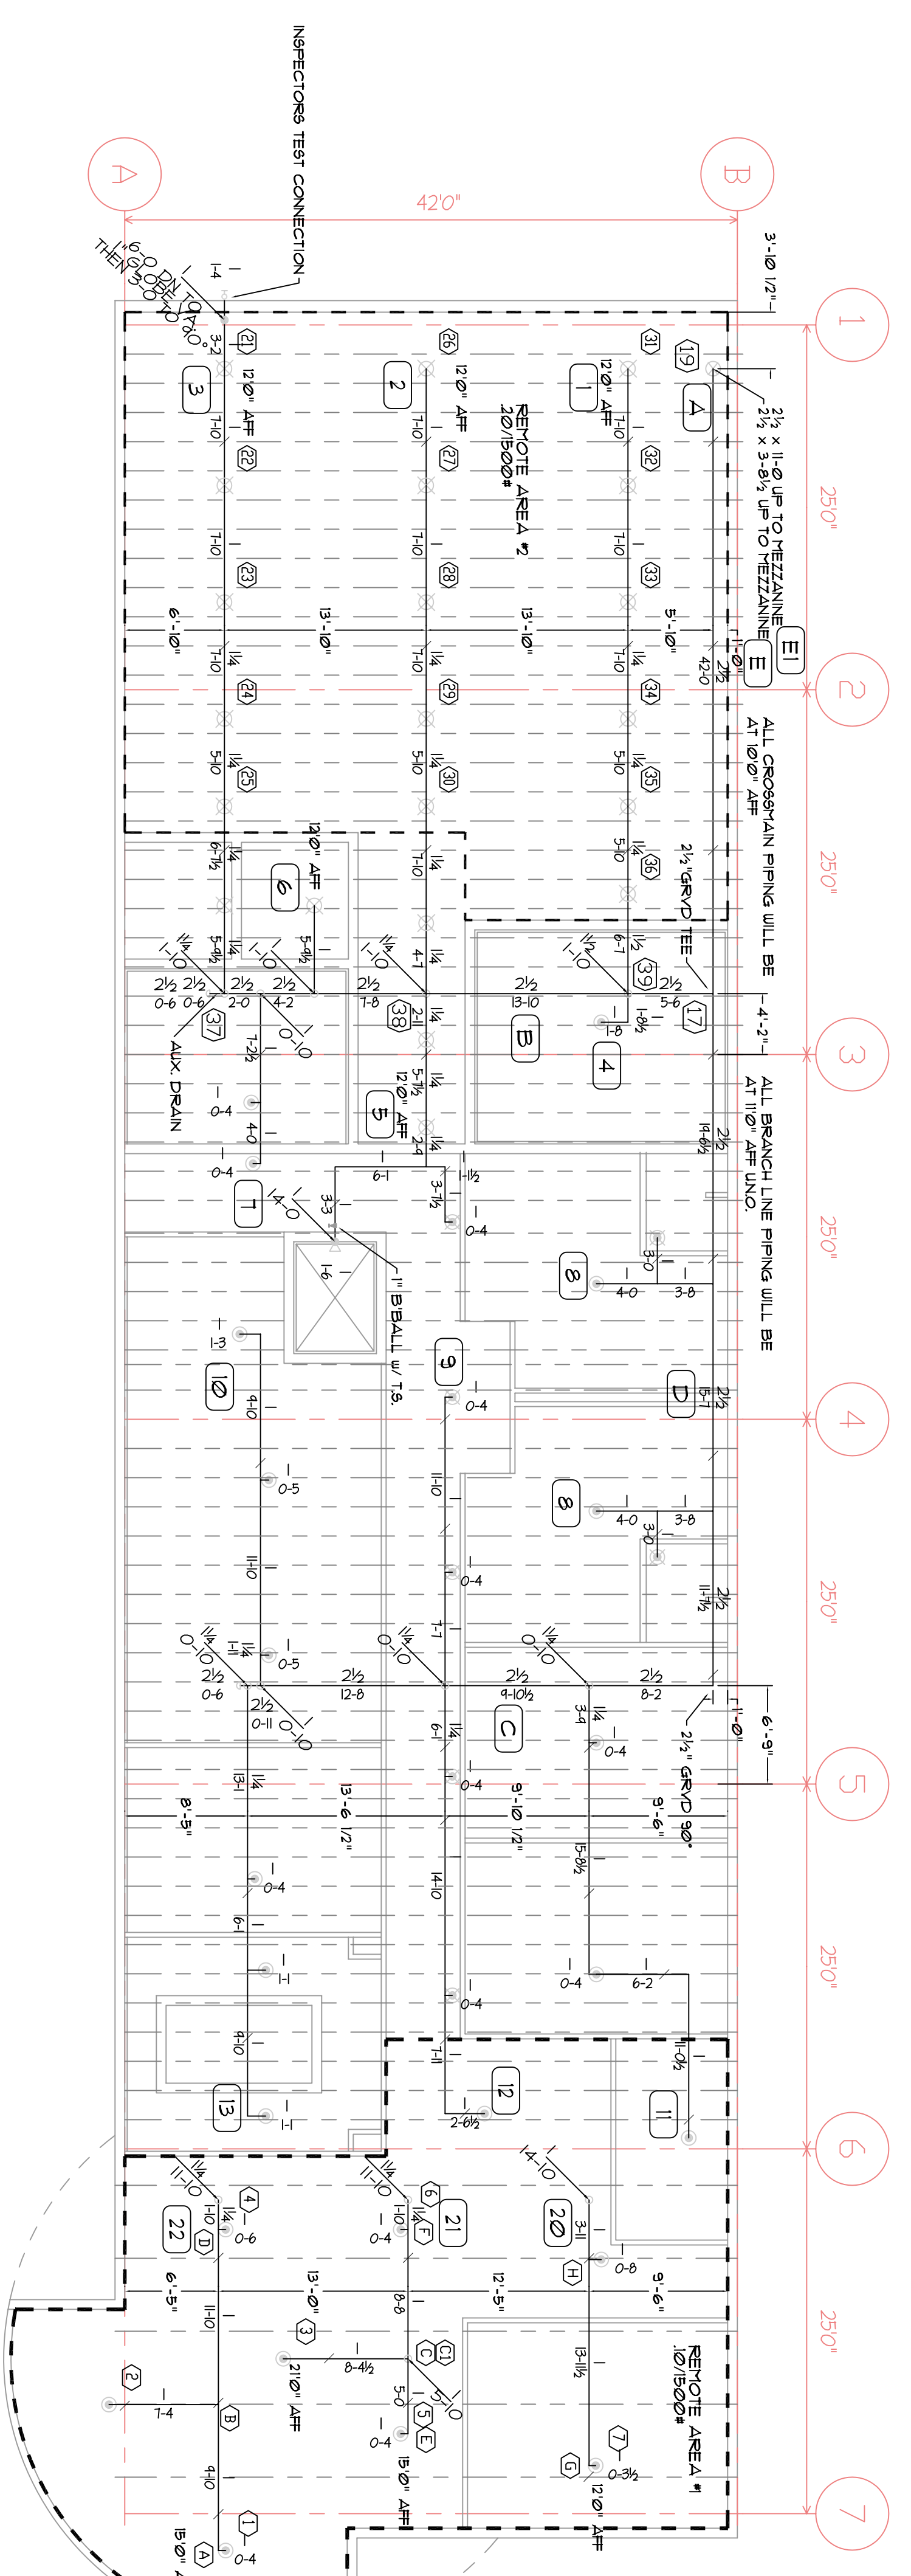

OFFICE AREA FIRE PROTECTION PLAN
SCALE: 1/8" = 1'-0"

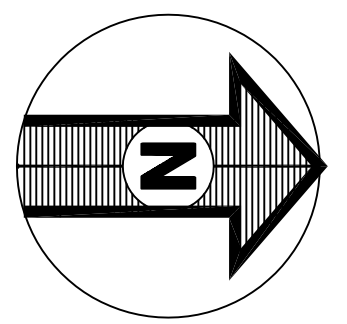

NO.	DATE	REVISIONS	BY

WATER SUPPLY INFORMATION			
STATD PRESSURE	75	FIRE FLOW	4000 GPM
RESIDUAL PRESSURE	55	SIZE OF MAIN	4\"/>
FLOOR IN CO.M.	3820	TYPE OF WIRING	ELECTRIC
DATE OF TEST	11/14/95	ELECTRICAL RES.	
TIME OF TEST			
TEST PANEL BY			
HYDRANT LOCATION			

DESIGN SUMMARY			
SYSTEM NO.	3	3	3
DESIGN AREA	10	20	20
DENSITY	100	100	100
DESIGN AREA SF	14878	12813	14452
PSY REQD @ FIVE DESIGN	14878	11223	63424
NO. SPRLK. IN DESIGN AREA	0	1	6
ELKS @ HIGHEST SPRLK	0	121	271
MINER. HOSE	0	0	0
OUTSIDE HOSE	0	250	250

SYMBOL		MANUAL	MANUAL	COMMENTS

SPRINKLERS			
SYMBOL	QUANTITY	SIZE	NOTE
	24	3/4"	1.65"
	24	3/4"	1.65"
	2	1/2"	1.65"
	21	1/2"	1.65"
	8	1/2"	1.65"
	79	TOTAL THIS SHEET	

PROJECT			

DRAWING INFORMATION			
SYSTEM NO.	1	DATE	
DRAWN BY	DAU	SCALE	1/8" = 1'-0"
CHECKED BY		SHEET NO.	3FP OF 4
DESIGN NO.			